


USTA 
NATIONAL CAMPUS

20'-8"

AFP
COURTS



FILE NAME: SUP SITE PLANS.DWG
DATE: 09/12/25
LAST MODIFIED ON: 09/12/25 12:49 PM
LAST MODIFIED BY: MICHAEL POINCE
PLOT FILED ON: 09/12/25 12:51 PM

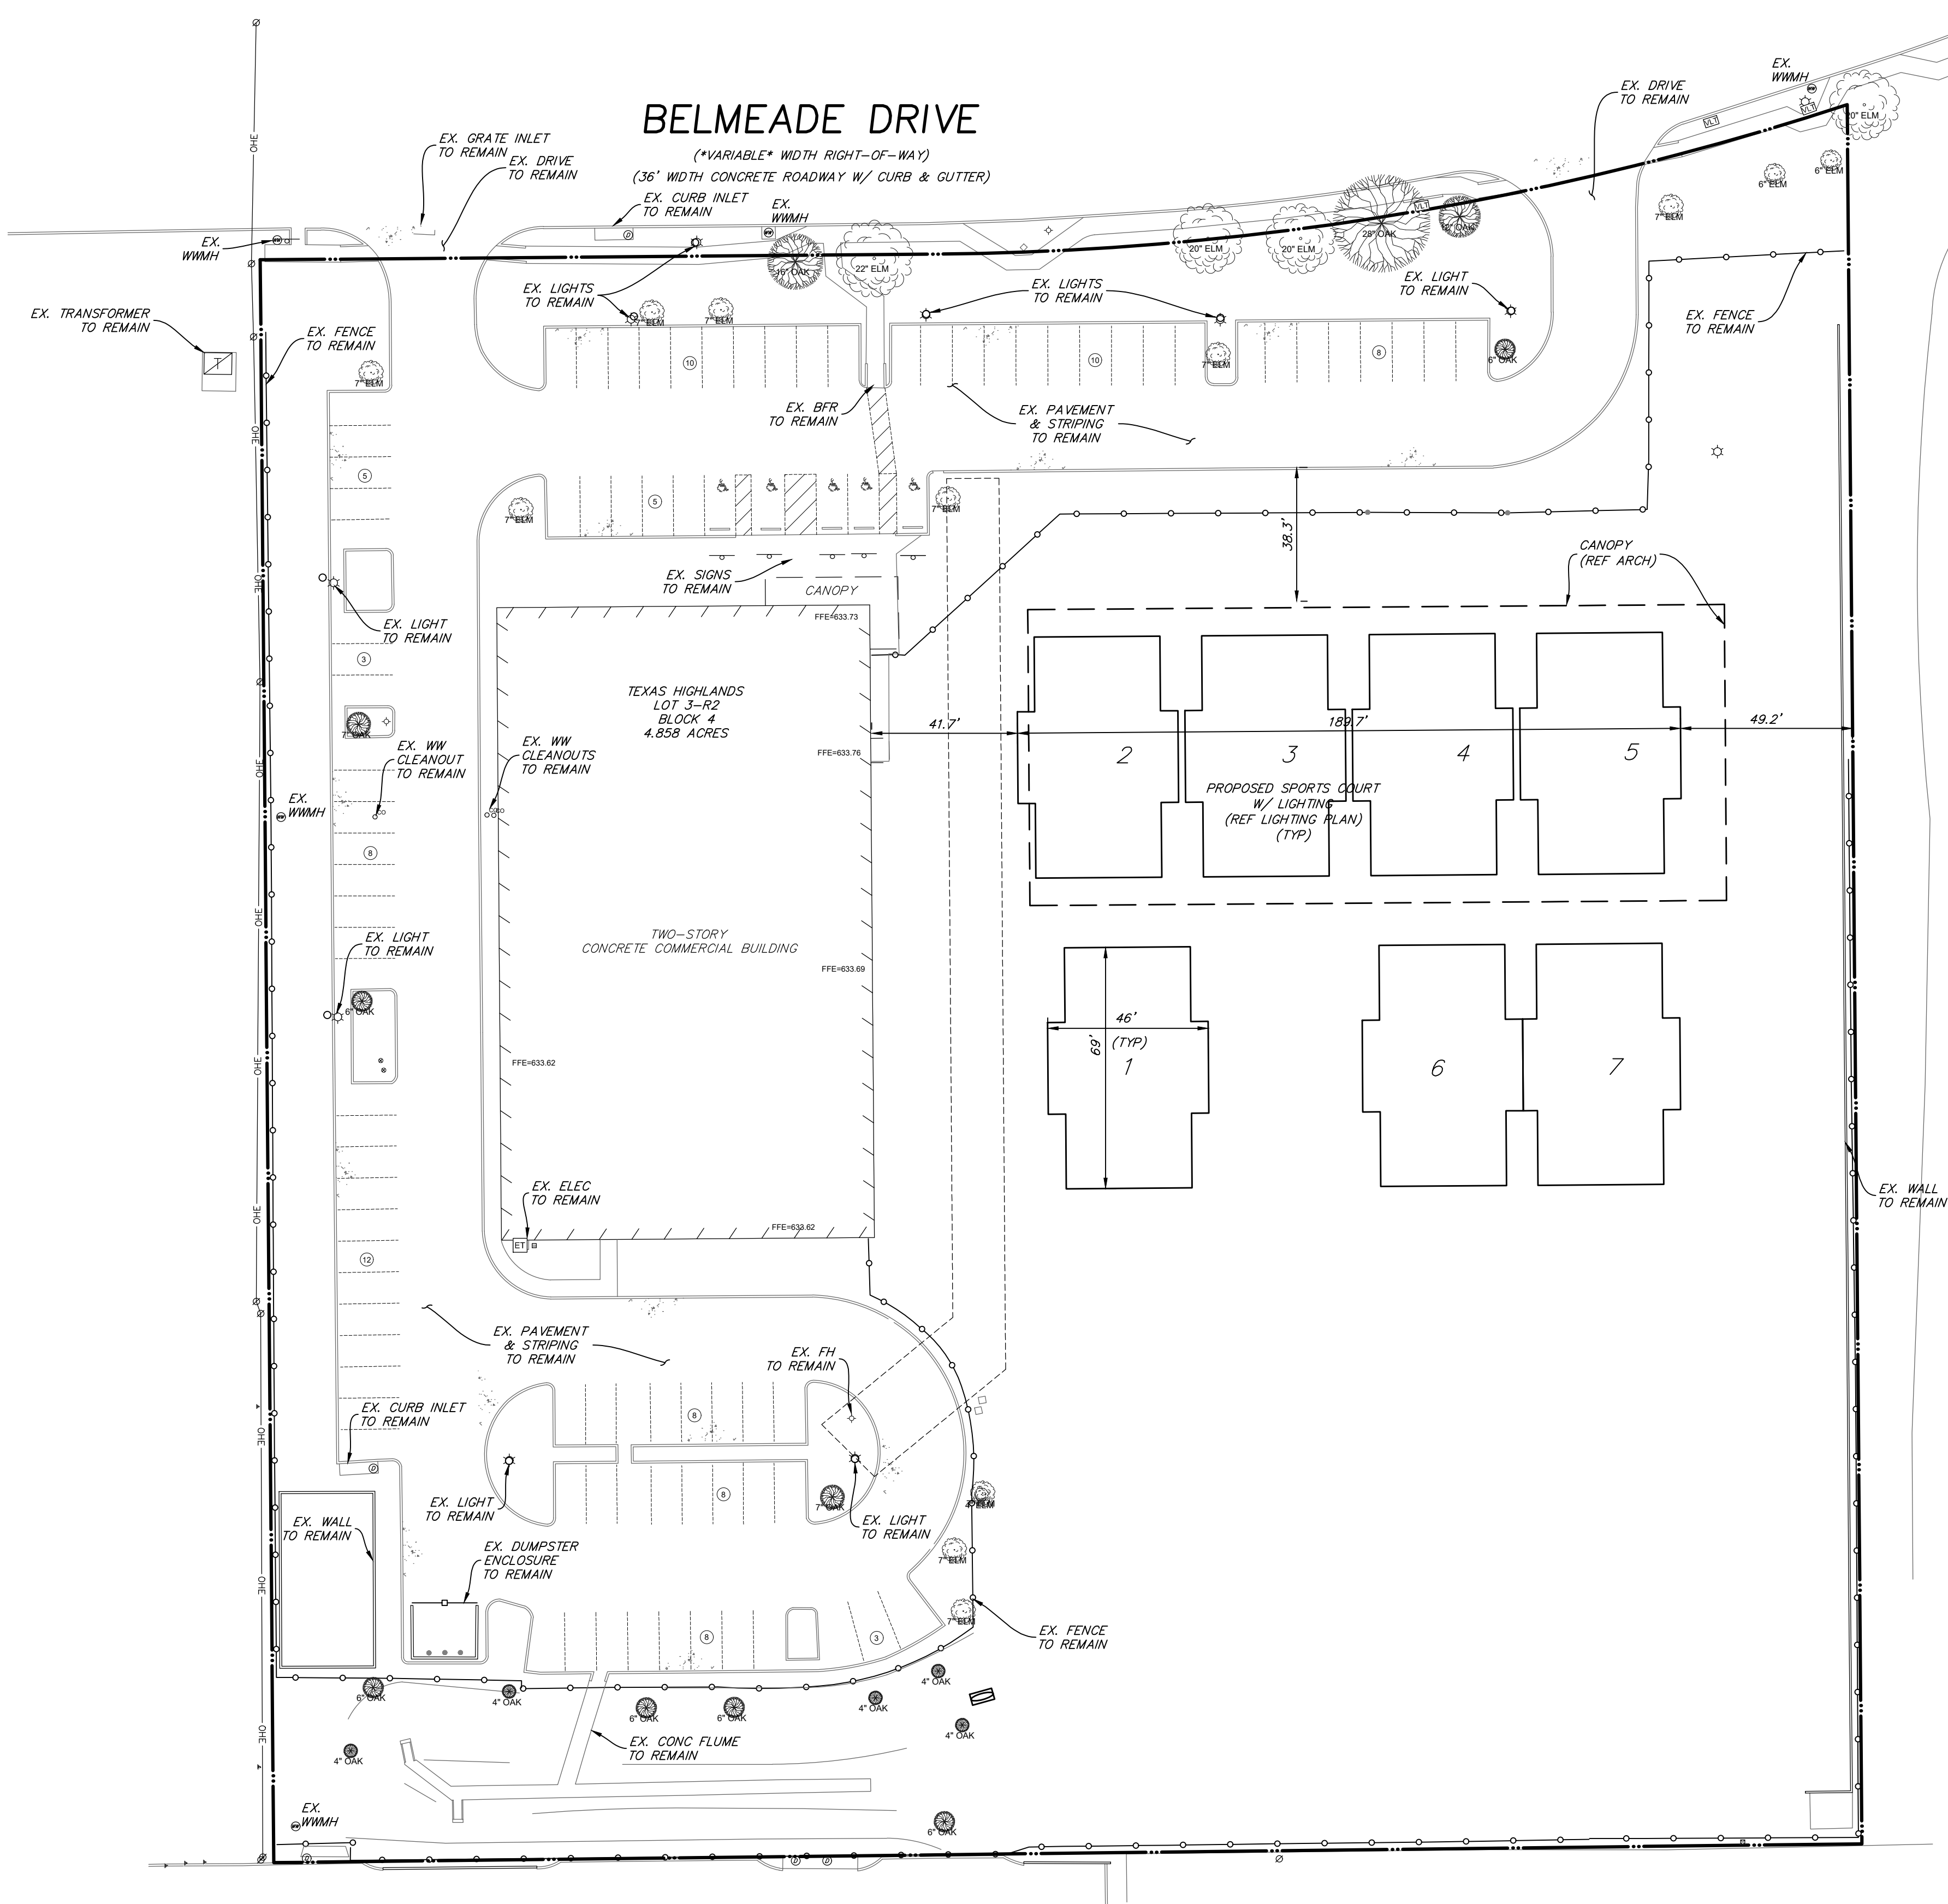


SITE/PAVING PLAN LEGEND

- PROPERTY LINE
- SAWCUT PATH
- EX. ASPHALT PAVEMENT
- EX. BUILDING LINE
- EX. FENCE LINE
- EX. OVERHEAD ELECTRIC
- FENCE LINE

- 2 PARKING COUNT
- LA LANDSCAPE AREA
- WWMH EX. WASTEWATER MANHOLE
- W EX. WATER MANHOLE
- D EX. STORM DRAINAGE MANHOLE
- EX. FIRE HYDRANT
- EX. TRANSFORMER
- EX. ELECTRIC BOX
- EX. ELECTRIC METER
- EX. SWITCH GEAR
- EX. SIGNAGE

EXISTING CONCRETE PAVEMENT

PROPOSED SPORTS COURT
(REF LIGHTING PLAN FOR ILLUMINATION DETAILS)
(REF ARCH FOR COURT & CANOPY DETAILS)

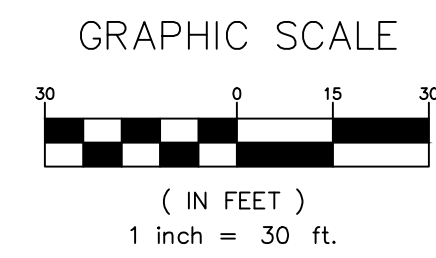

City File No. PLSUP 2025-119

INITIAL SUBMITTAL 06/24/25
2ND SUBMITTAL 09/12/25

BENCHMARK DATA:

TBM-1 = 04-J-1. A SQUARE IS CUT ON THE CONCRETE BASE AND LEG. AT THE NORTHEAST CORNER OF T.P.&L. TOWER #65.925. WEST OF VAIL STREET AND 120' NORTH OF BRIARGROVE LANE. ELEV.: 643.66'

TBM-2 = 03-L-1. A SQUARE IS CUT ON TOP OF A CONCRETE CURB ON THE EAST SIDE OF KELLY BOULEVARD AND 80' NORTH OF THE CENTERLINE OF SEEDLING LANE. ELEV.: 562.91'


PRELIMINARY

NOT FOR CONSTRUCTION,
BIDDING, OR PERMIT PURPOSE.

PREPARED UNDER THE
SUPERVISION OF
DOUGLAS E. BARRILLEAUX
P.E.# 97518
ON

www.urbanstrategy.us

TEL: 214.396.2339

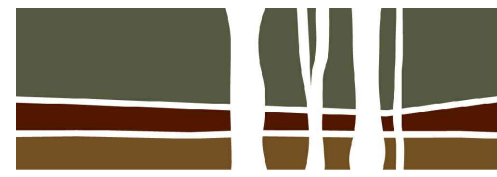

la terra studiosm

landscape architecture
park planning

12001 N. CENTRAL EXPY. - SUITE 1170
DALLAS, TEXAS - 75243
469.955.3658

www.latterastudio.com

STAMP:

DALLAS PADEL CLUB
LIGHTING SUP
3000 BELMEADE DRIVE
CARROLLTON, TEXAS 75006



NO. DATE ISSUE/REVISION

LTS PROJECT # 25003

DRAWN BY MP

CHECKED BY DB

DATE September 12, 2025

DRAWING TITLE

CIVIL SITE PLAN
(LIGHTING SUP)

DRAWING NUMBER

SP